
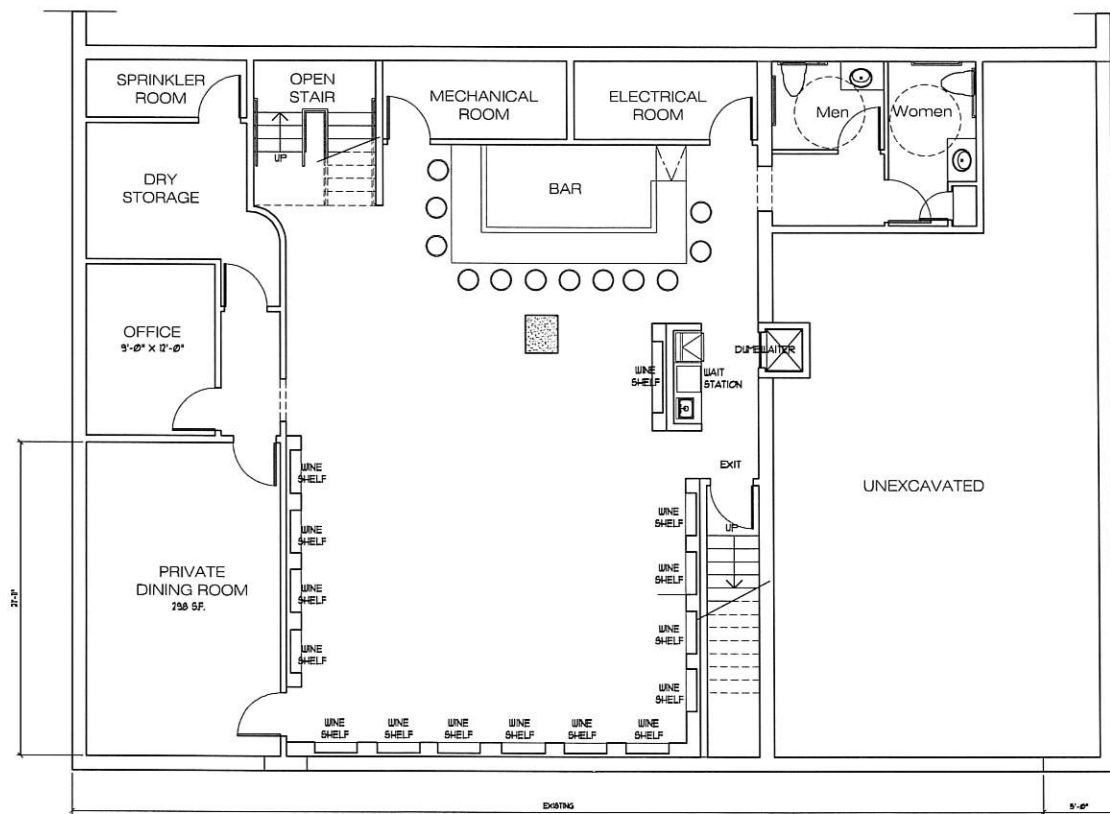


1 Main Level Floor Plan  
1/4" = 1'-0"

Progress Print  
March 22, 2019


 <p><b>THA ARCHITECTS, LLC</b> ARCHITECTURE/PLANNING/INTERIOR DESIGN 105 WILLOW BROOK AVENUE STRATHAM, NEW HAMPSHIRE 03885 Tel: (603) 770-2491 Fax: (603) 773-0238 WWW.THAAARCH.COM</p> <p><small>These drawings and specifications were prepared for use at the location indicated. Reproduction and use by others is prohibited without the written permission of THA Architects, LLC. © 2019 THA Architects, LLC.</small></p>
Ciao Italia
60 Main Street Durham, NH
Main Level Floor Plan
Mechanical/Plumbing Engineer <b>WV Engineers</b> Electrical Engineer <b>WV Engineers</b> Fire Protection Engineer <b>WV Engineers</b>
SCALE: ISSUED / DRAWN BY REVISER / REVISED BY
JOB NO: 19004 SHEET NUMBER <b>A-1.2</b>

RECEIVED  
Town of Durham  
APR 17 2019  
Planning, Assessing  
and Zoning



1 Lower Level Floor Plan  
1/4"=1'-0"

Progress Print  
March 22, 2019

 <p><b>THA</b> ARCHITECTS, LLC</p> <p>ARCHITECTURE • INTERIOR DESIGN</p> <p>105 WILLOW BROOK AVENUE STRATHAM, NEW HAMPSHIRE 03885</p> <p>Tel: (603) 770-2491 Fax: (603) 773-0238 WWW.THAAFC.COM</p> <p><small>These drawings and specifications were prepared for use on the location indicated. Publication and use in excess of those to the intended location, without the written consent of the author, is prohibited. In whole or in part, is considered a violation of the copyright of THA Architects, LLC.</small></p> <p>© 2019 THA Architects, LLC.</p>
Ciao Italia
60 Main Street Durham, NH
Lower Level Floor Plan
Mechanical/Plumbing Engineer <b>WV Engineers</b> Electrical Engineer <b>WV Engineers</b> Fire Protection Engineer <b>WV Engineers</b>
SCALE:
ISSUED / DRAWN BY
REVISOR / REVISED BY
JOB NO: 19004
SHEET NUMBER <b>A-1.1</b>